

**GENERAL NOTES & DISCLAIMERS**

- ALL BUILDINGS DESIGNED AND CERTIFIED IN ACCORDANCE WITH NTH STANDARD DRAWINGS. BUILT TO BCA REQUIREMENTS.
- PLUMBING AND ELECTRICAL WIRING DONE IN ACCORDANCE TO AUSTRALIAN STANDARDS.
- FURNITURE, PLUMBING & ELECTRICAL ITEMS FOR INDICATIVE PURPOSE ONLY.
- ALL BUILDINGS ARE MANUFACTURED TO WIND SPEED: REGION C, IMPORTANCE LEVEL 2

CLIENT APPROVAL:  
 CLIENT NAME:  
 DATE (DD-MM-YYYY):  
 SIGNATURE:

**SYMBOL/LEGEND**

	SWITCHED OUTLET 10A DOUBLE GPO		DISTRIBUTION BOARD
	SINGLE LIGHT SWITCH		DISTRIBUTION BOARD EXTERNAL POINT OF ATTACHMENT
	SWITCHED OUTLET 10A SINGLE		TV EXTERNAL JUNCTION BOX FOR AERIAL CONNECTION
	TV POINT		CEILING FAN
	EXTERNAL WEATHERPROOF DOUBLE SOCKET		HARD WIRED SMOKE DETECTOR
	DATA OUTLET		ISOLATOR
	EXHAUST FAN		1200mm LED LIGHT FITTING C/W DIFFUSER
	BUNKER LIGHT		

**REVISION/AMENDMENT**


REV	DATE	BY	DESCRIPTION

REV DATE BY DESCRIPTION




HIRE - CRIB ROOM  
 12x3m - Crib Room  
 PLAN & ELEVATIONS

CHECKED (PO):	RH	CHECKED (PM):	GW
DRAWN BY:	NP	DRAWN DATE:	SCALE: 1 : 100
SHEET:	S01	SHEET SIZE:	A3
		REVISION:	

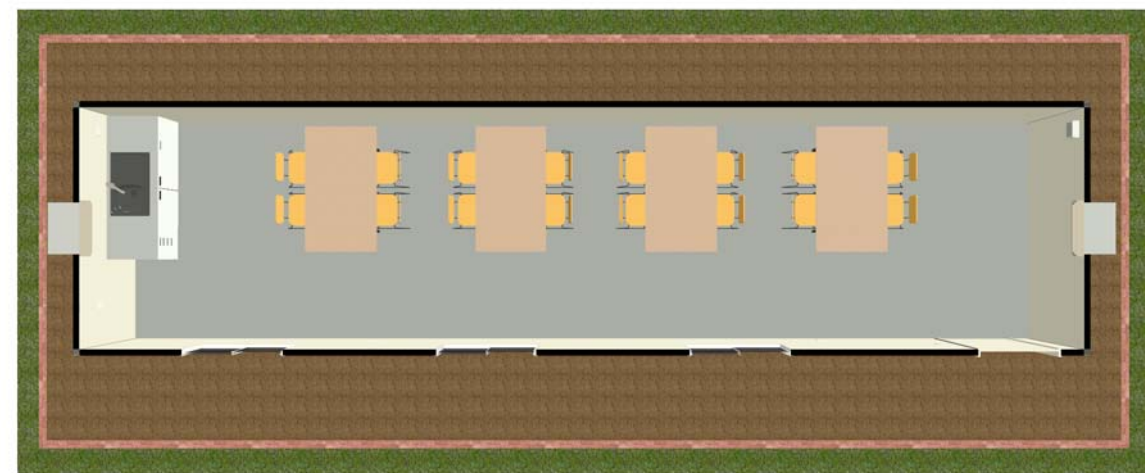


CRIB ROOM

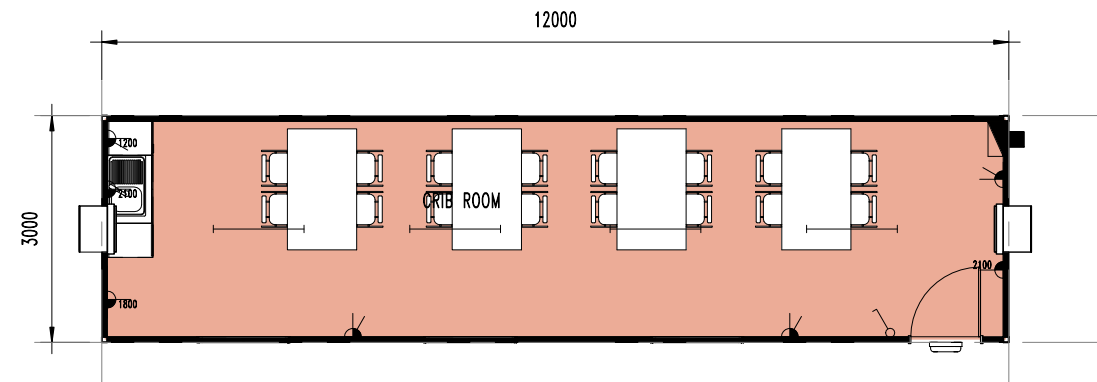


**A FLOOR PLAN**  
1 : 100




**OPEN PLAN - 3D**

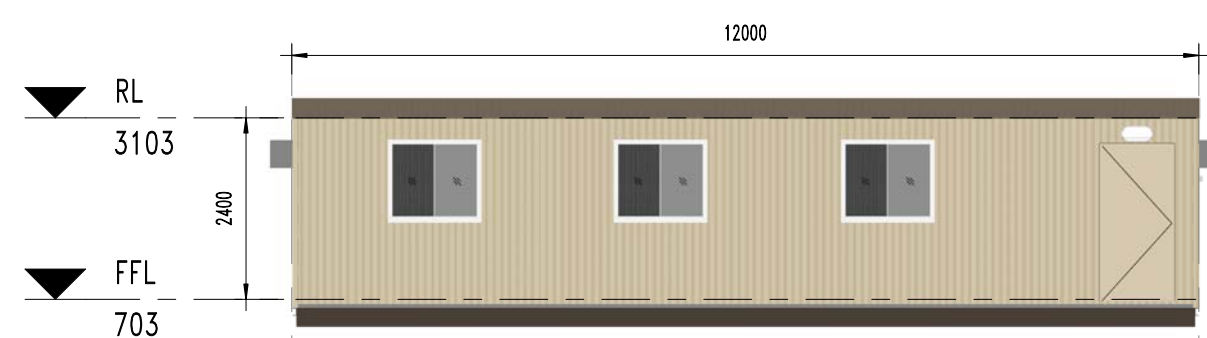

**1 ELEVATION**  
1 : 100

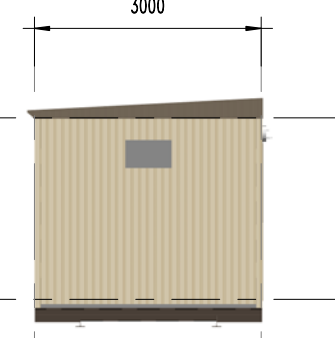

**2 ELEVATION**  
1 : 100

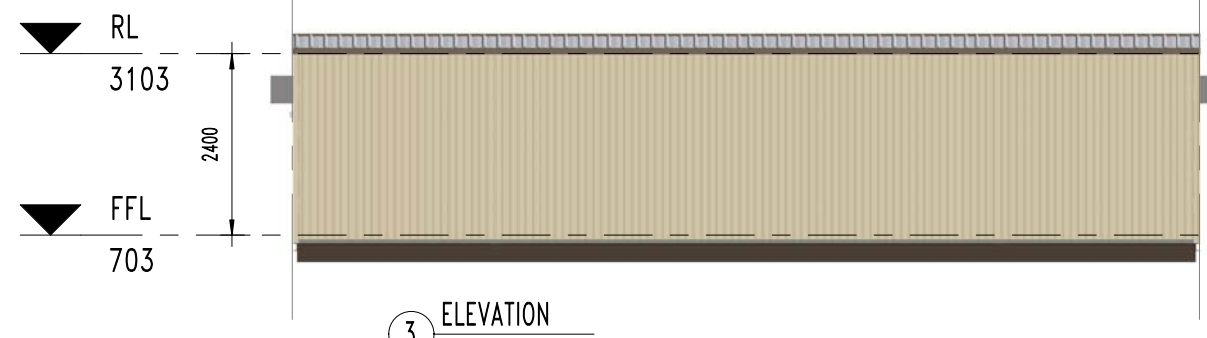

**3 ELEVATION**  
1 : 100



**4 ELEVATION**  
1 : 100



**OPEN PLAN - 3D**

**ELEC/HYDRO/FURNISHING SCHEDULE**

TAG	QTY	DESCRIPTION
1	2	RAC AIR CONDITIONER

DOOR SCHEDULE				
TAG	QTY	HEIGHT	WIDTH	ITEM
D1	1	2040	920	EXTERNAL DOOR
W1	3	1050	1190	SLIDING GLASS WINDOW

28/01/2021 9:48:36 AM

Copy Right  
 This drawing is the property of Northern Transportables Pty. Ltd. It must not be loaned, copied, reproduced or shown to third parties without authority and written consent of Northern Transportables.